




ARCHITECTURAL DRAWINGS

FOR

7-L + TOILET (G+1)

SAMAGRA SHIKSHA

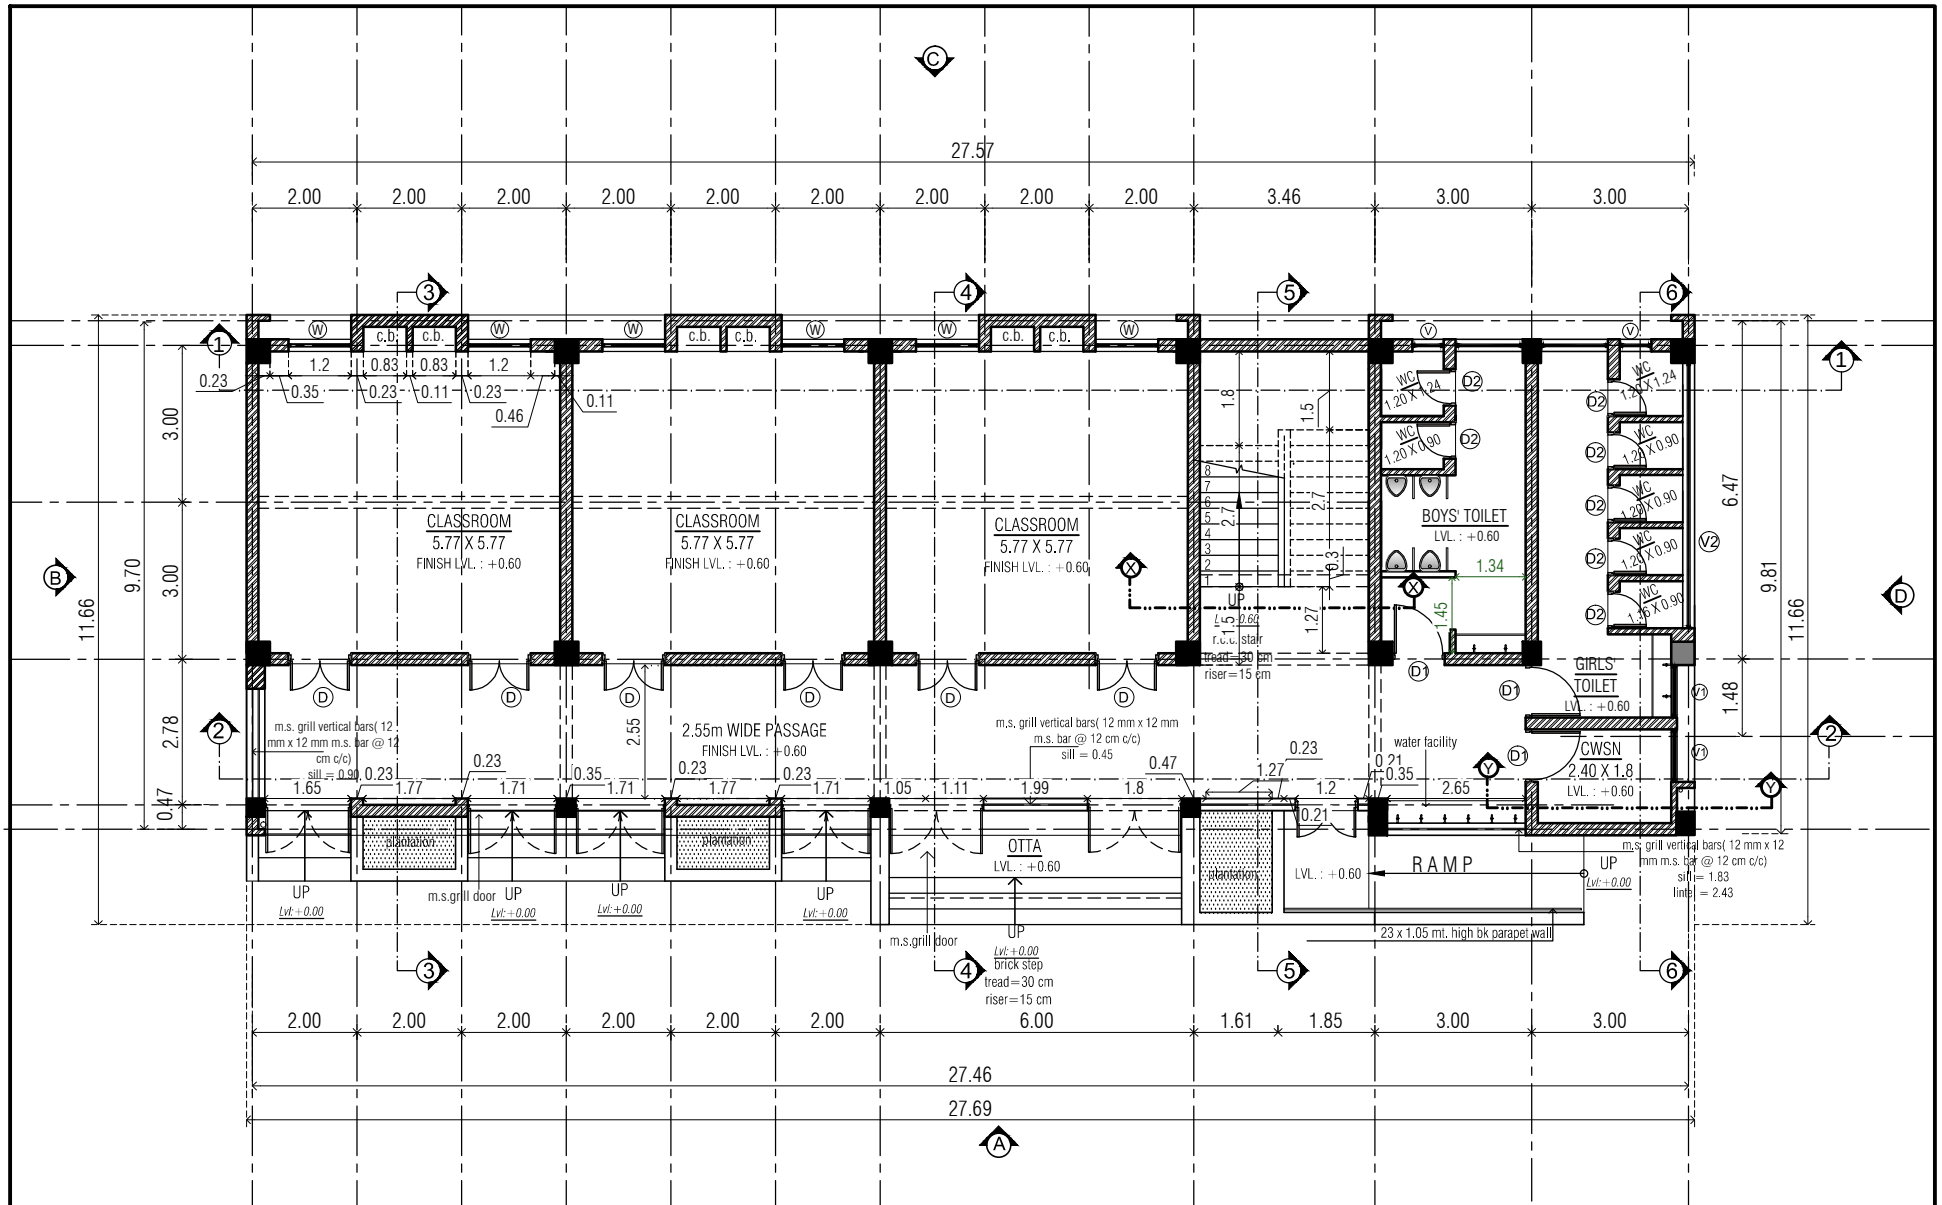


GROUND FLOOR PLAN

DOOR WINDOW SCHEDULE					
TYPE	SIZE	LINTEL	SILL	NOS.	LOCATION
D	1.20 X 2.43	BEAM BOTTOM	-	14	CLASS ROOM
D1	1.00 X 2.43	-	-	03	CWSN TOILET, TOILET
D2	0.70 X 2.00	2.00	-	07	TOILETS
D3	1.20 X 2.13	-	-	01	STAIRCABIN
W	1.20 X 1.98	BEAM BOTTOM	0.45	14	CLASS ROOM
V	0.60 X 0.60	BEAM BOTTOM	-	02	TOILET
V1	1.00 X 0.60	BEAM BOTTOM	-	02	CWSN, TOILET
V2	5.02 X 0.31	BEAM BOTTOM	-	01	BOYS TOILET

PROJECT	7-4. CLASSROOMS + TOILET BLOCK
PLACE :	TALUKA :
DIST :	
DRAWN BY :	
SCALE : N.T.S.	
DATE :	

DRG.NO.


1/9

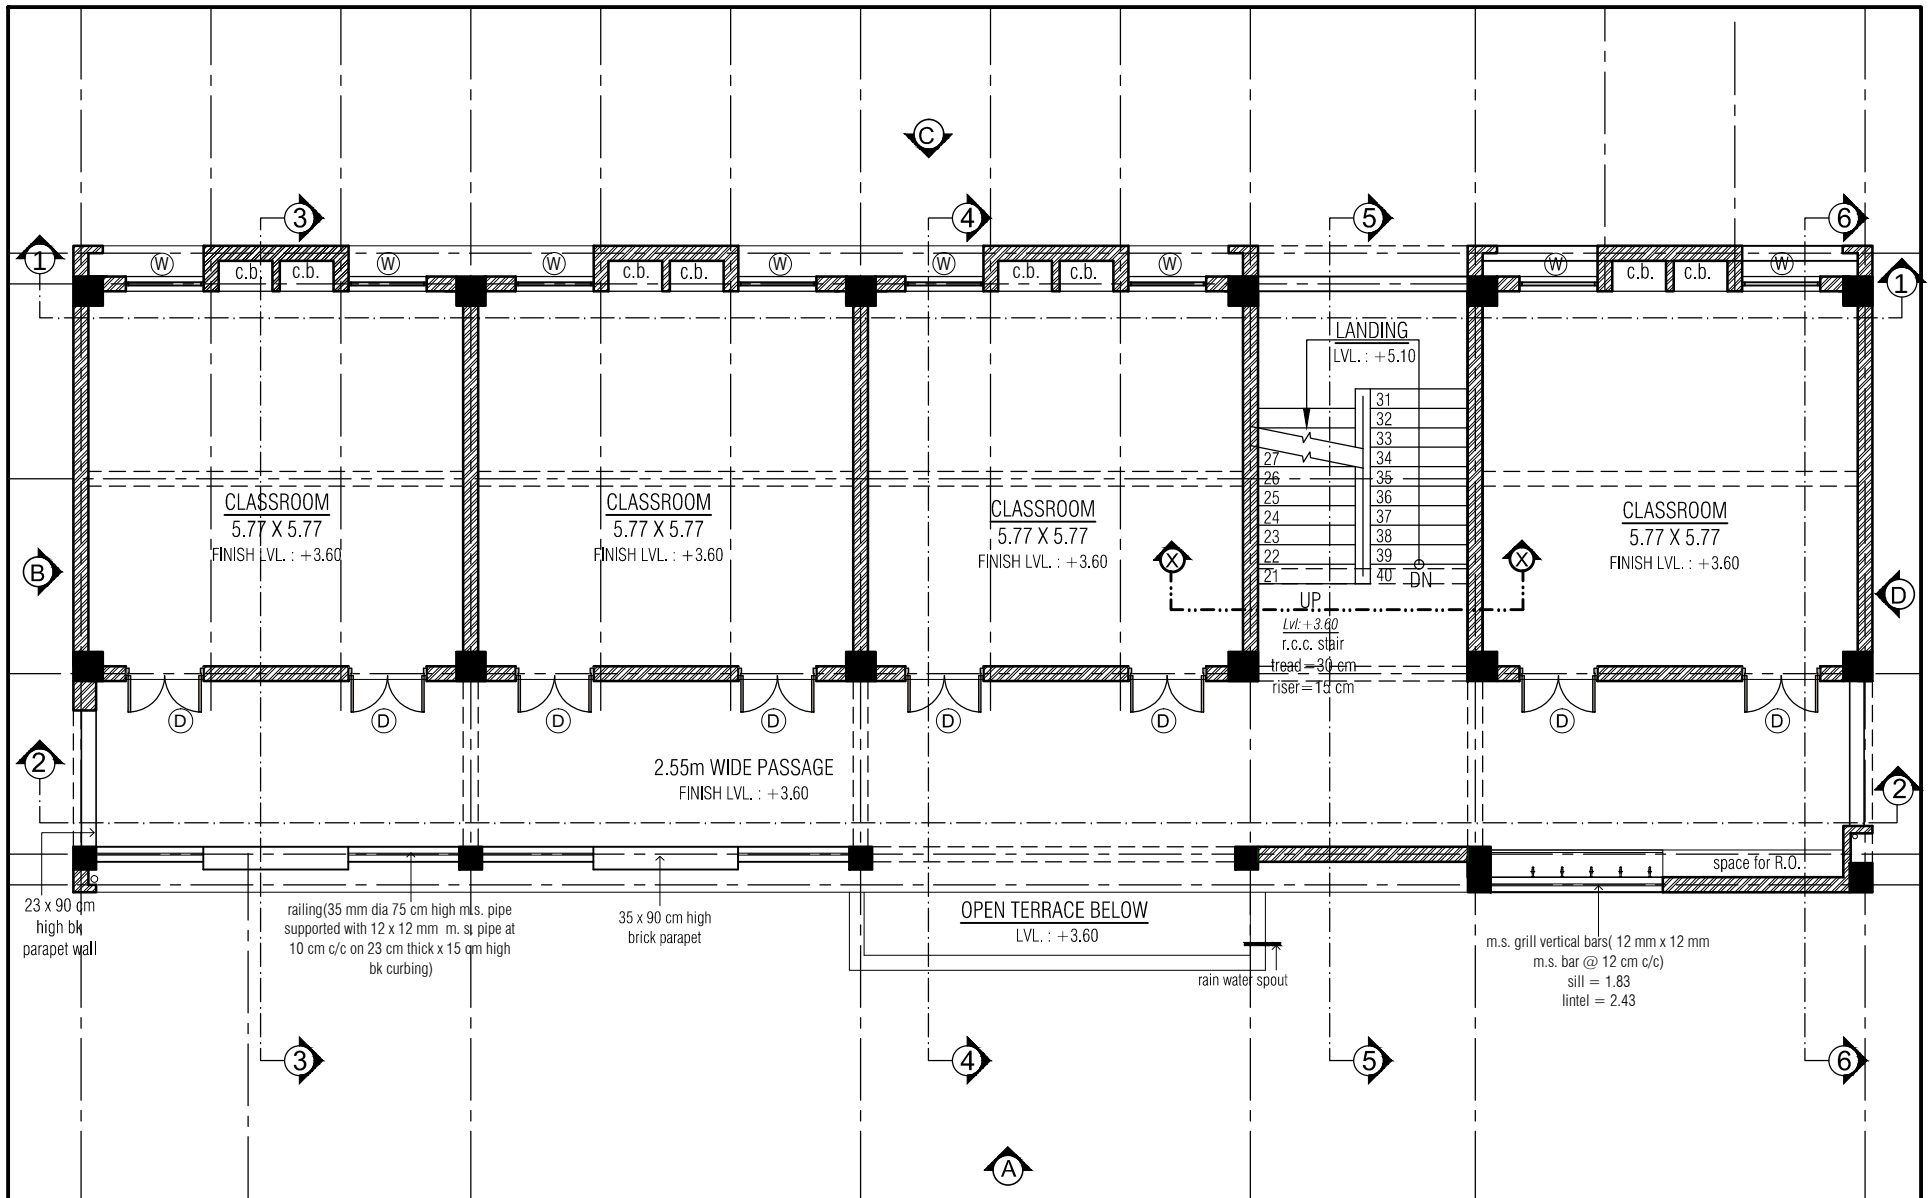

FIRST FLOOR PLAN

PROJECT
7-L CLASSROOMS + TOILET BLOCK
PLACE :
TALUKA :
DIST :
DRAWN BY :
SCALE : N.T.S.
DATE :

DRG.NO.
2/9

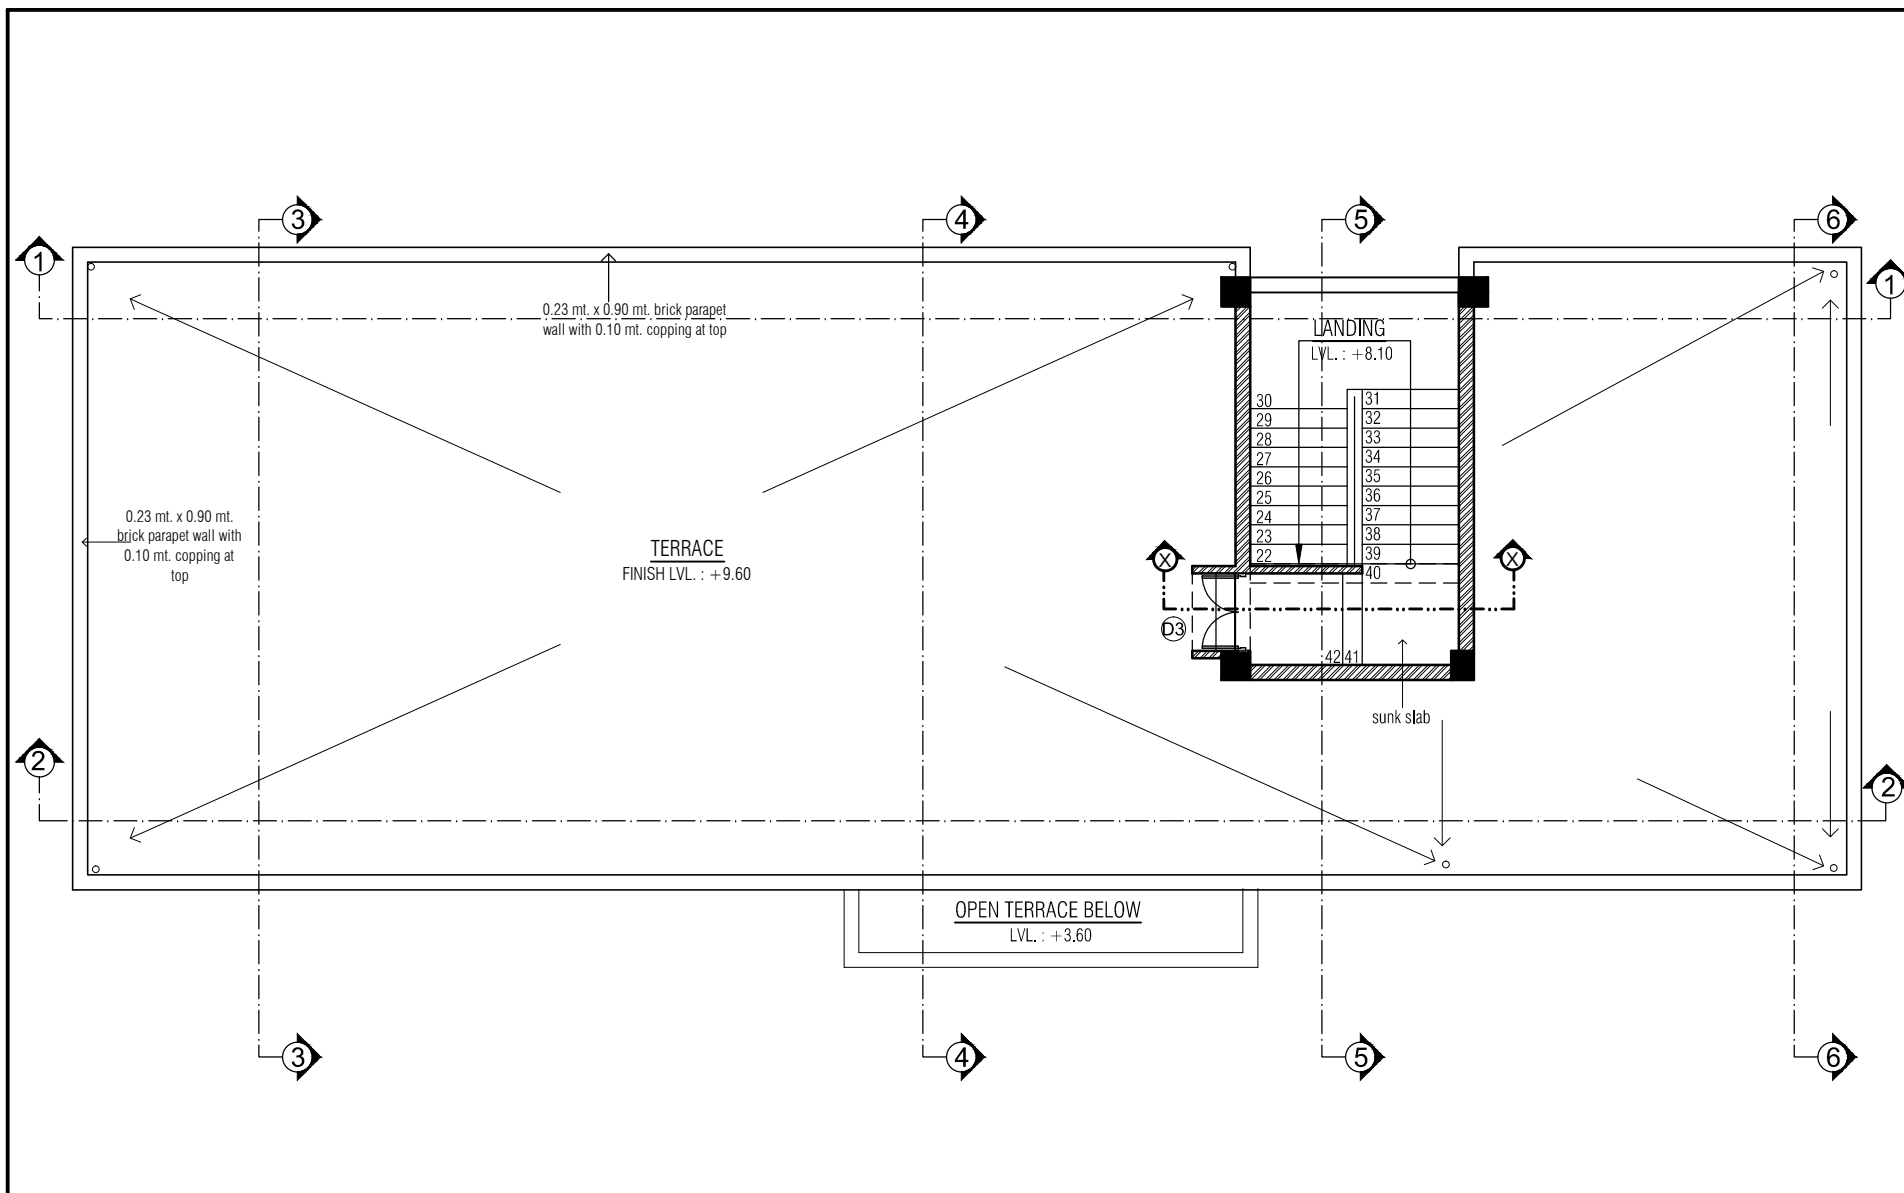

TERRACE PLAN

PROJECT
7-L CLASSROOMS + TOILET BLOCK
PLACE :
TALUKA :
DIST :

DRAWN BY :


SCALE : N.T.S.

DATE :

DRG.NO.


3/9

0.23 mt. x 1.00 mt. brick parapet wall

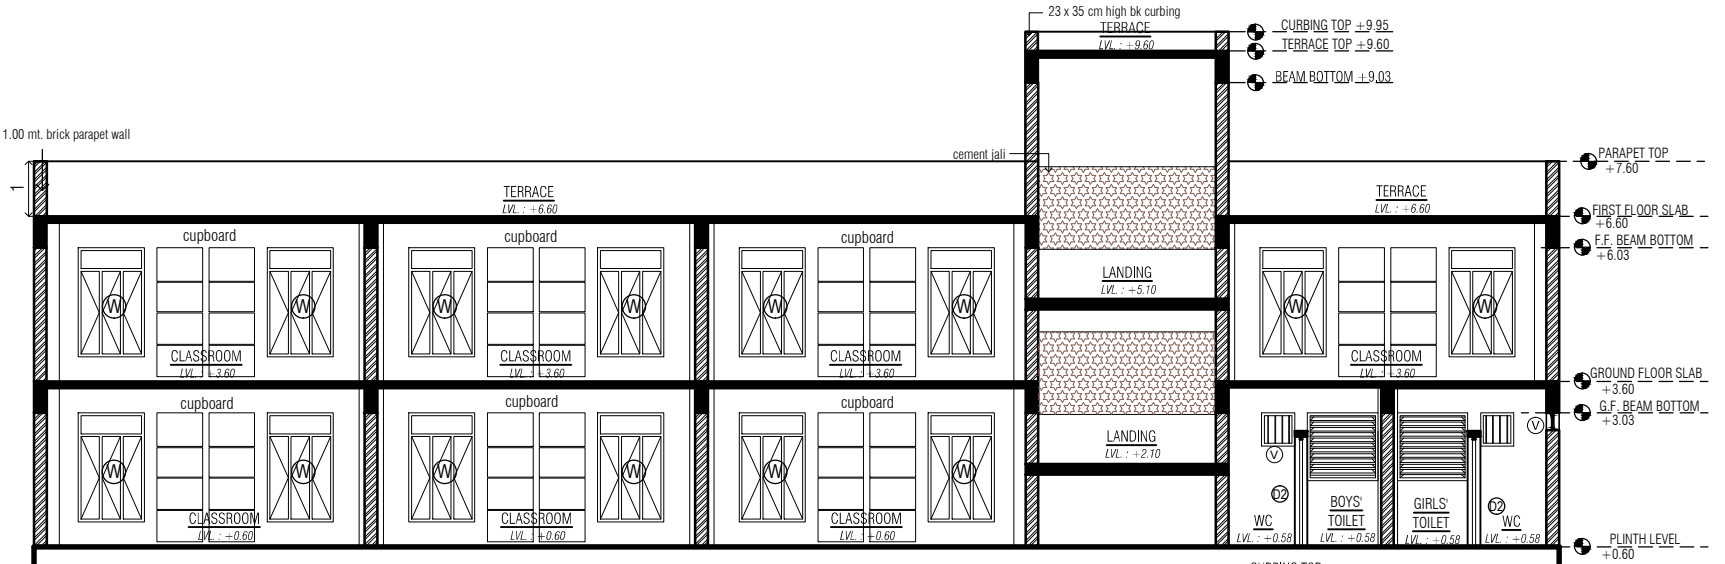

SECTION -1-1

0.23 mt. x 1.00 mt. brick parapet wall

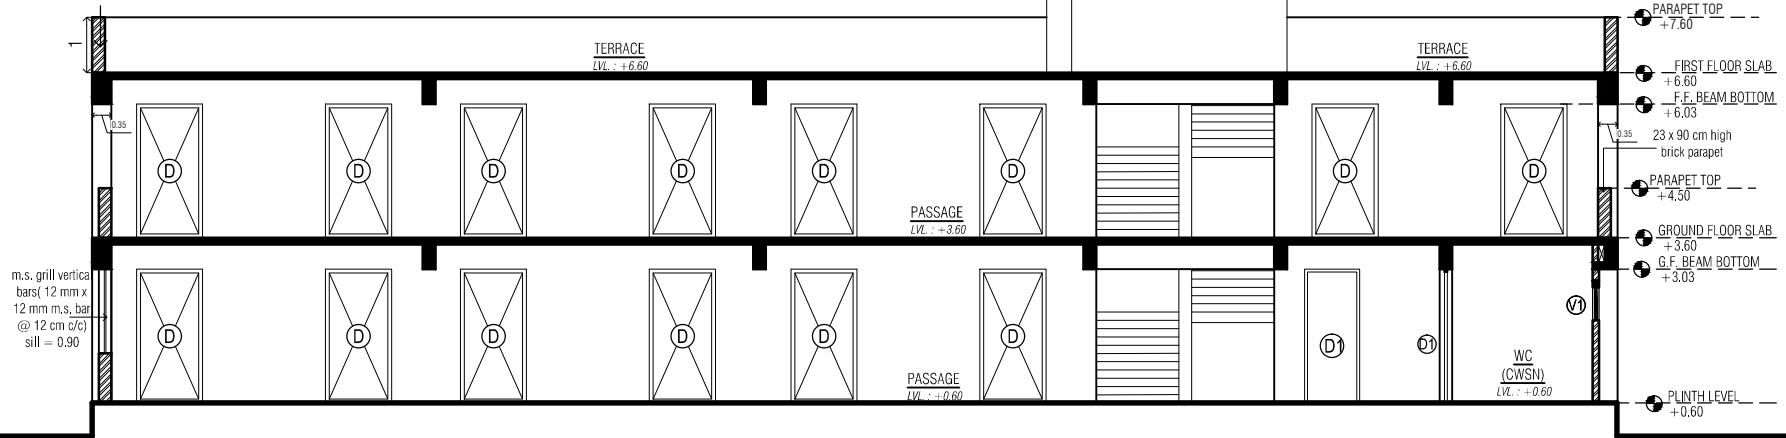


SECTION -2-2

SECTIONS


PROJECT
7-1. CLASSROOMS + TOILET BLOCK
PLACE :
TALUKA :
DIST :
DRAWN BY :
SCALE : N.T.S.
DATE :

DRG.NO.

4/9

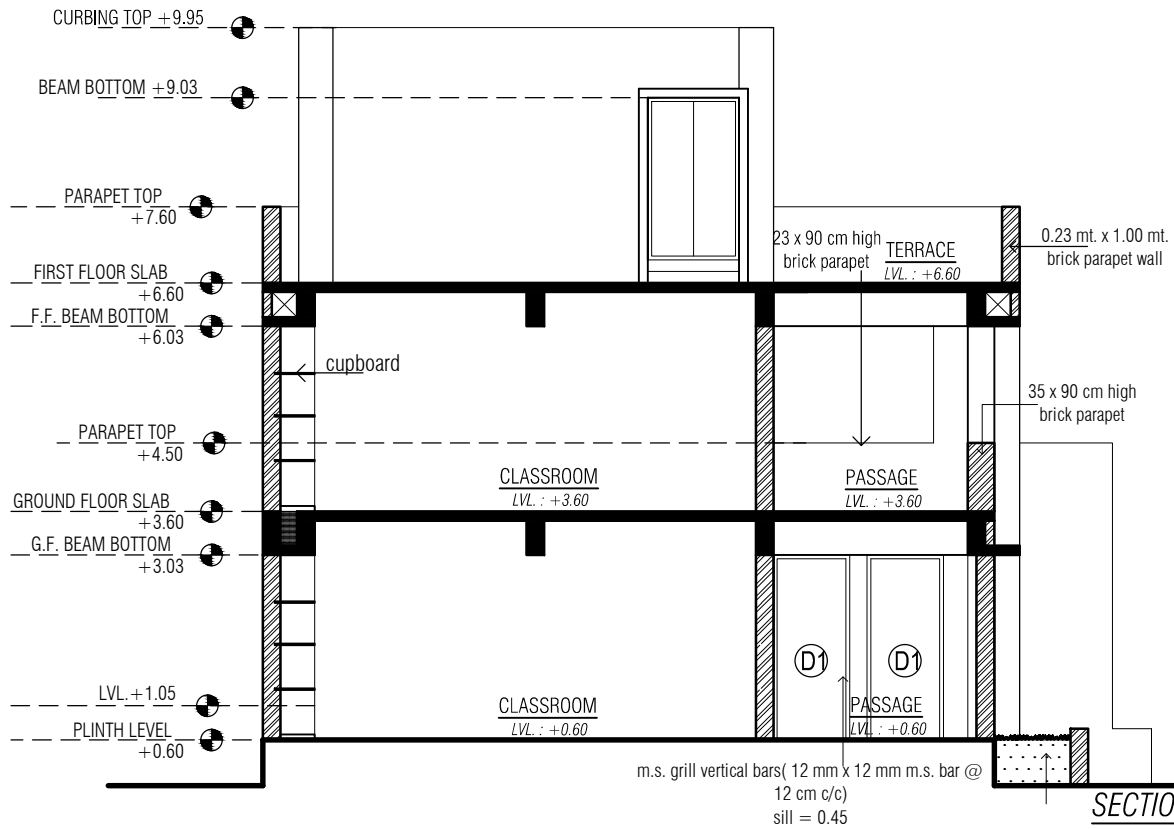

SECTION - 3-3

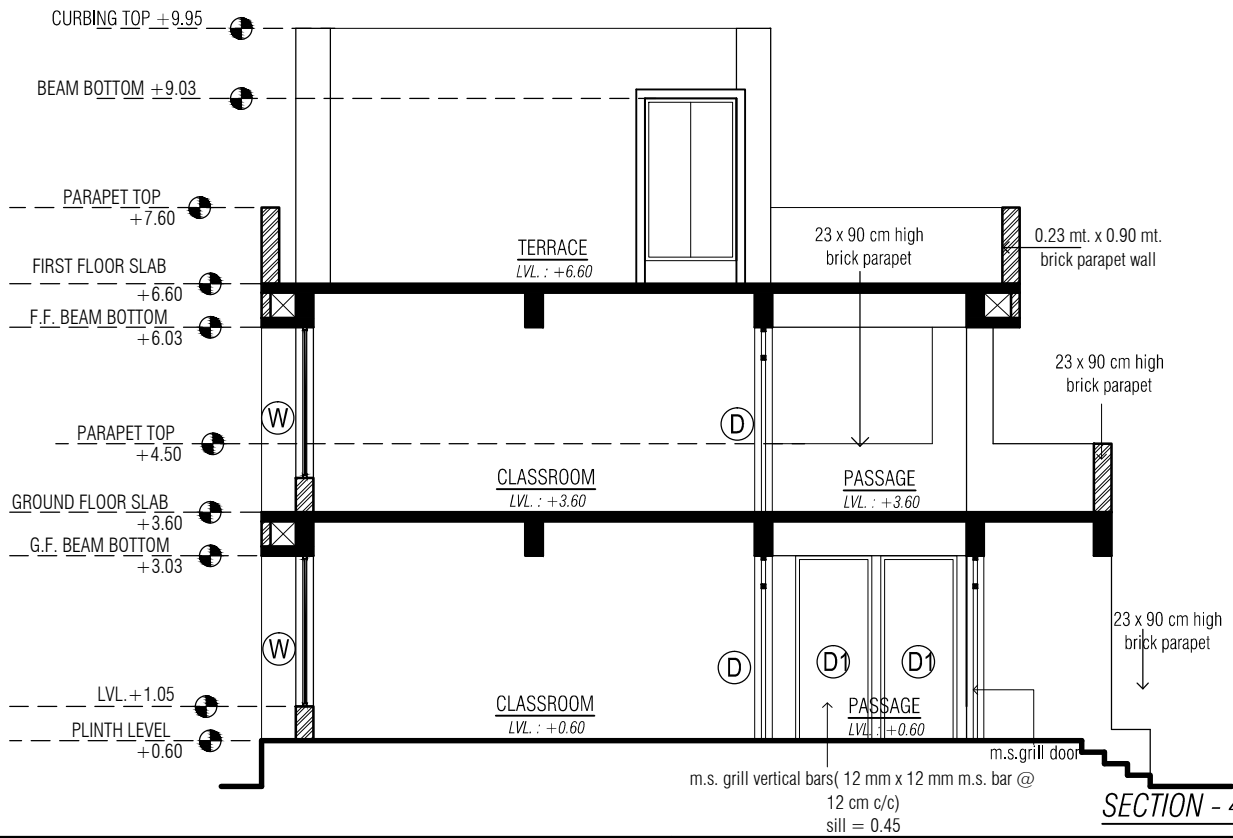

SECTION - 4-4

SECTIONS

PROJECT


7-L CLASSROOMS + TOILET BLOCK

S.S.A
ARCHITECT
SAUMIL GAJJAR


DRAWN BY : NIRALI PANDYA
SCALE : N.T.S.
DATE :

DRG.NO.

5/9

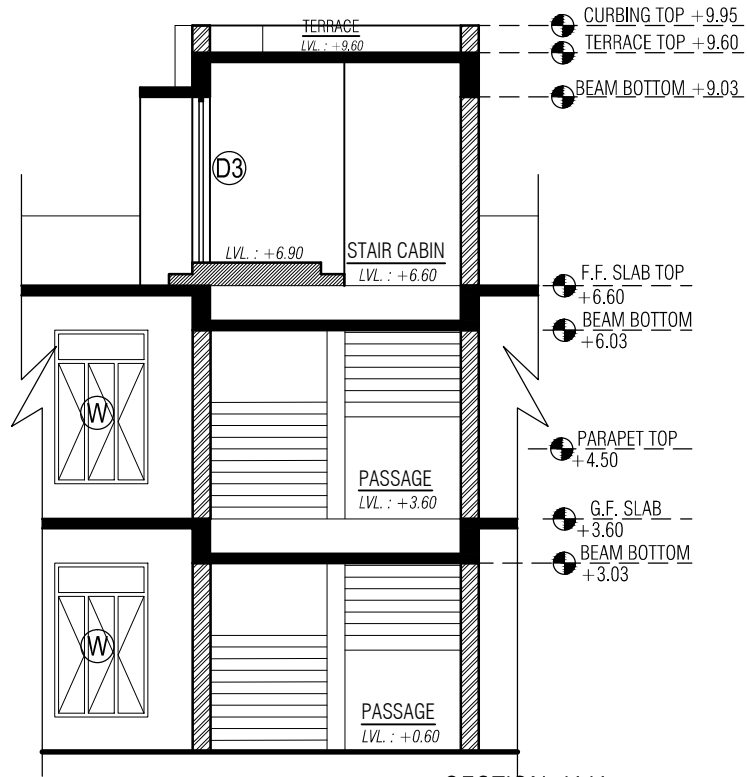

SECTION -X-X

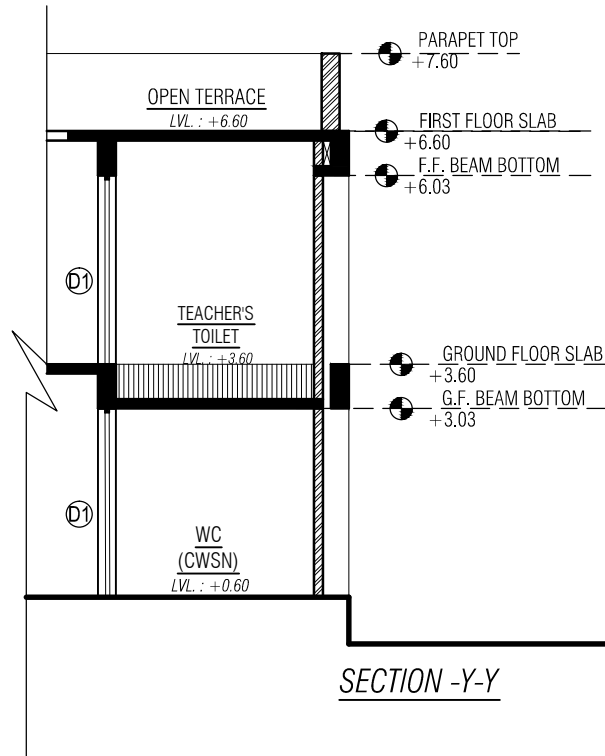

SECTION -Y-Y

SECTIONS


9-L CLASSROOMS + TOILET BLOCK

S.S.A
ARCHITECT
SAUMIL GAJJAR


DRAWN BY : NIRALI PANDYA
SCALE : N.T.S.
DATE :

DRG.NO.

5/8

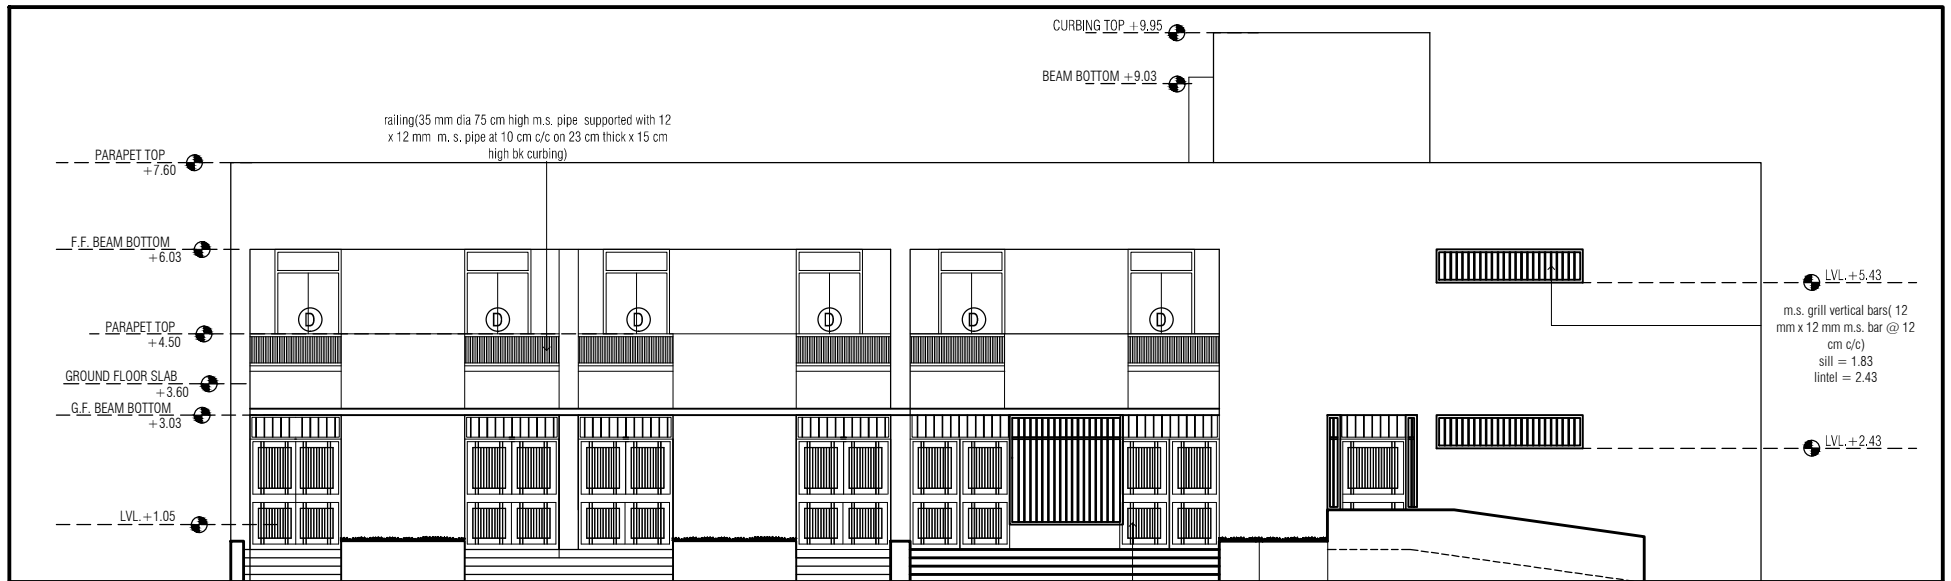

ELEVATION - A


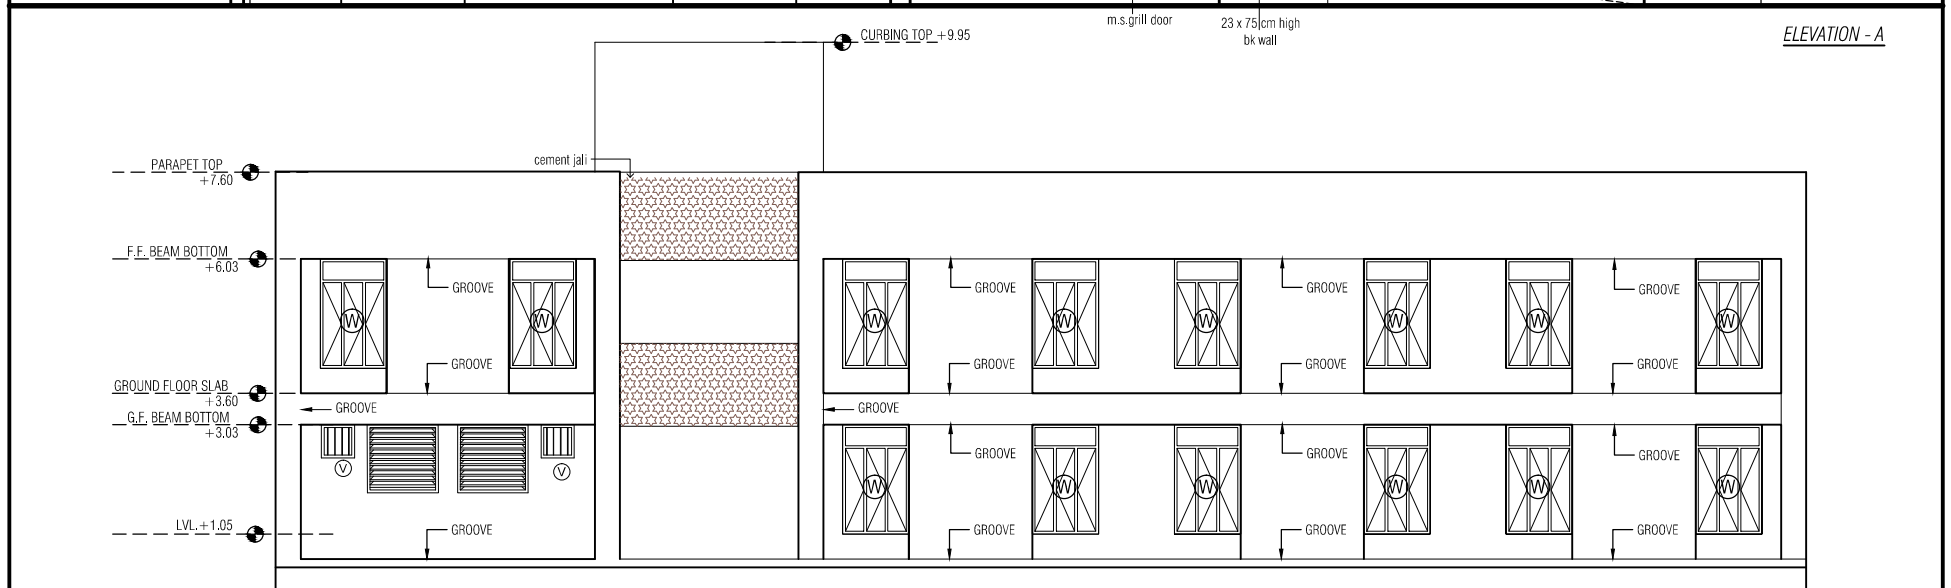


ELEVATION - C

ELEVATIONS

PROJECT
7-L CLASSROOMS + TOILET BLOCK
PLACE :
TALUKA ;
DIST
DRAWN BY :
SCALE : N.T.S.
DATE :

DRG.NO.
8/9

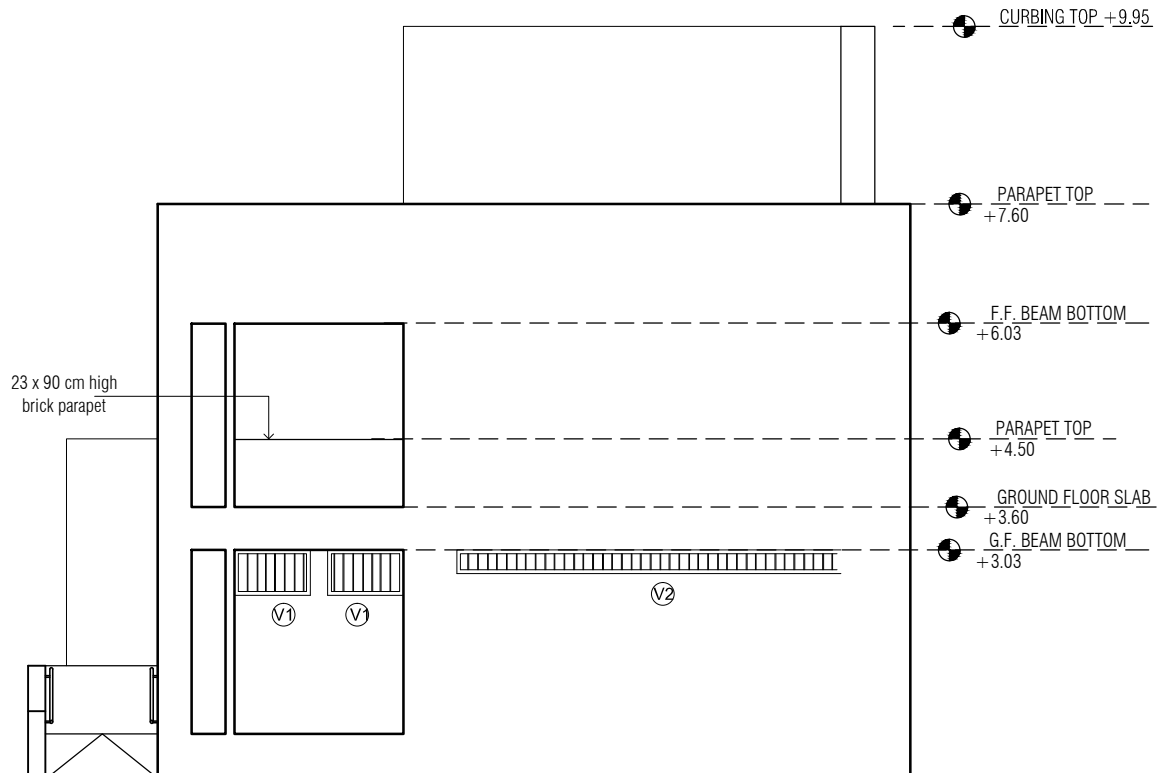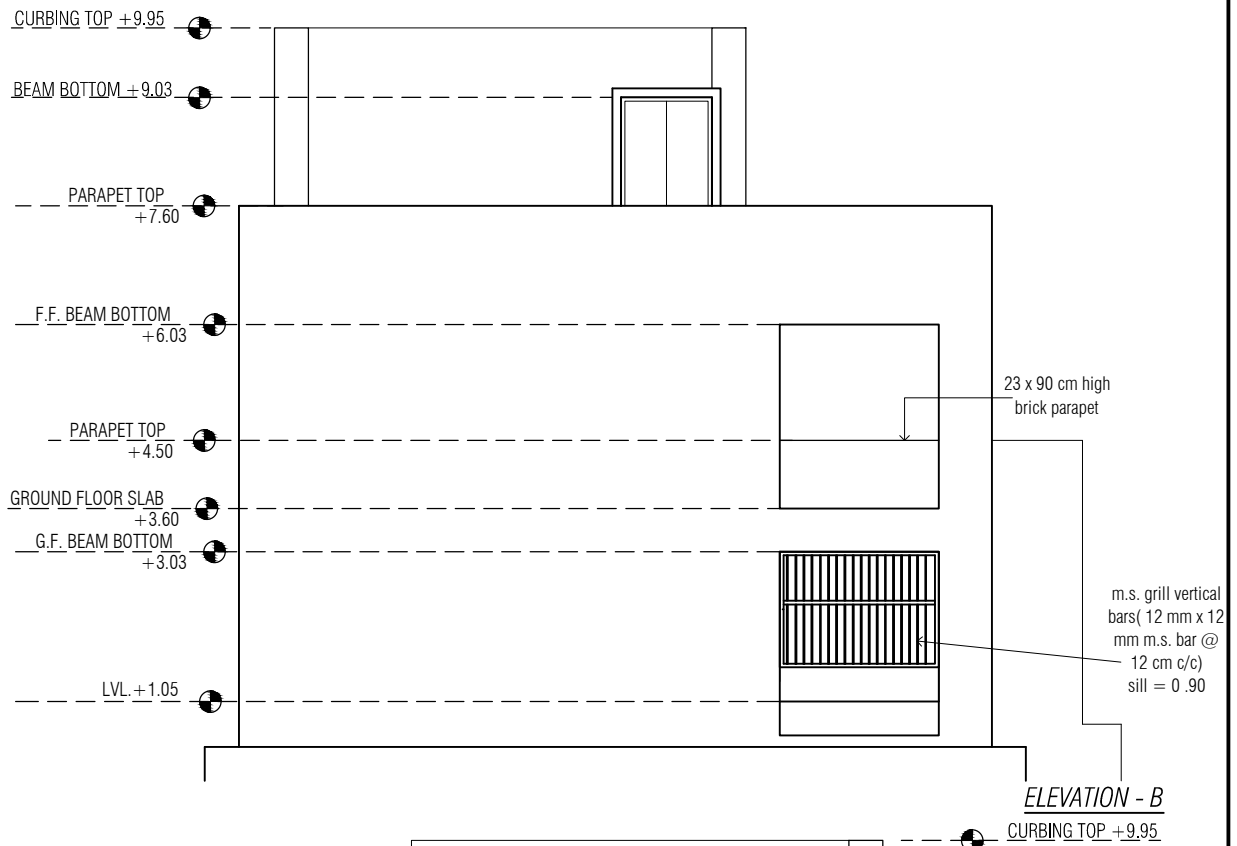

ELEVATIONS

PROJECT

7-L CLASSROOMS + TOILET BLOCK

S.S.A
ARCHITECT
SAUMIL GAJJAR


DRAWN BY : NIRALI PANDYA

SCALE : N.T.S.


DATE :

DRG.NO.


9/9

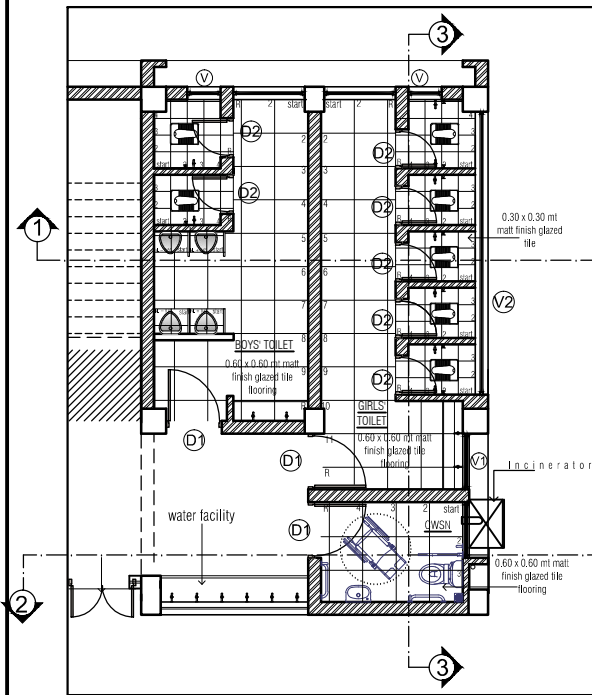

GROUND FLOOR PLAN

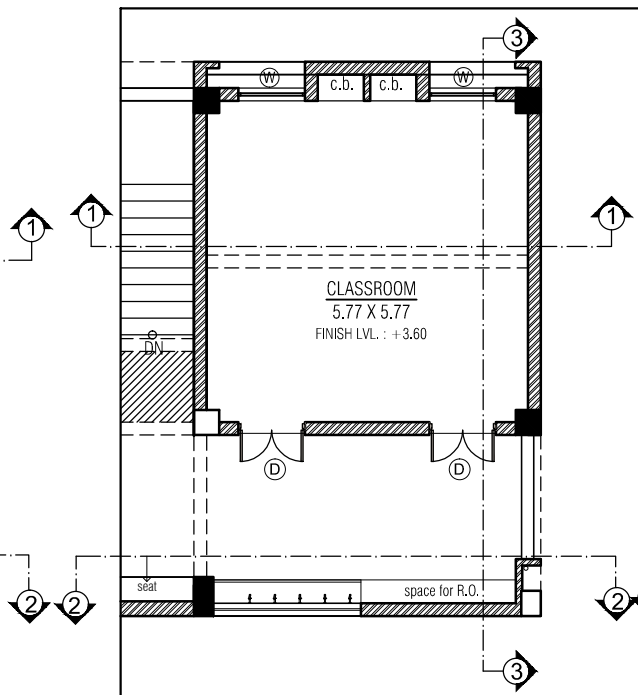

FIRST FLOOR PLAN

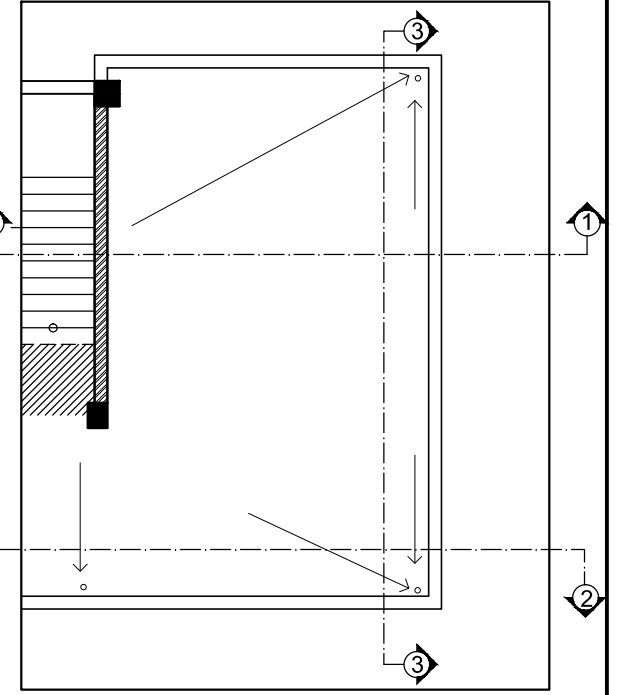

TERRACE PLAN

TOILET DETAIL - FLOOR PLAN

PROJECT
7-L + TOILET - REVISE

S.S.A




DRAWN BY : NIRALI PANDYA

DRG.NO.

SCALE : N.T.S.


DATE : 18/5/17

1/8

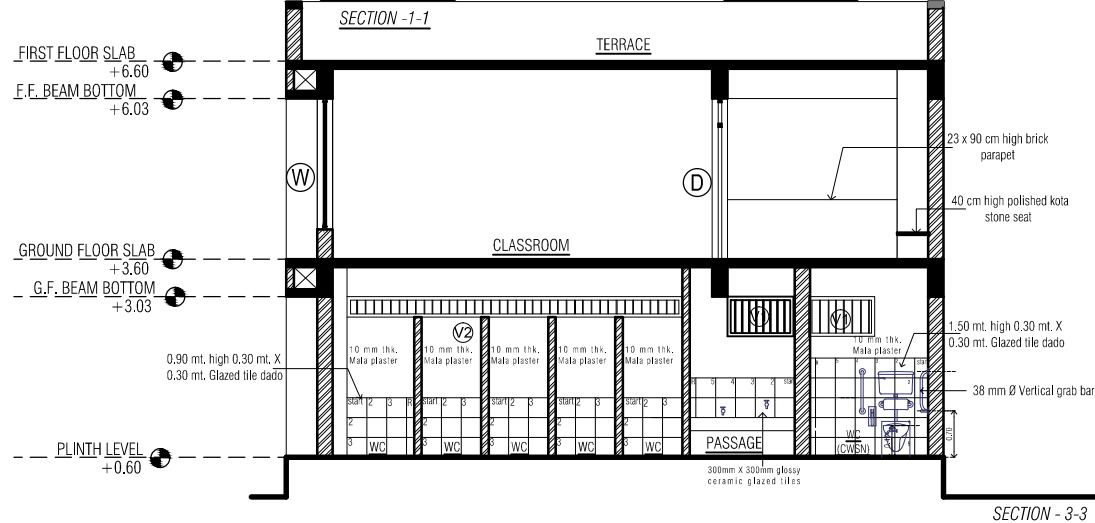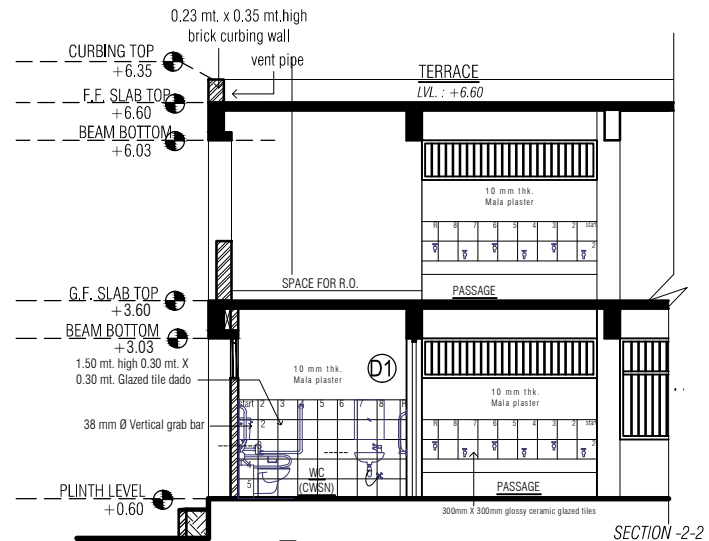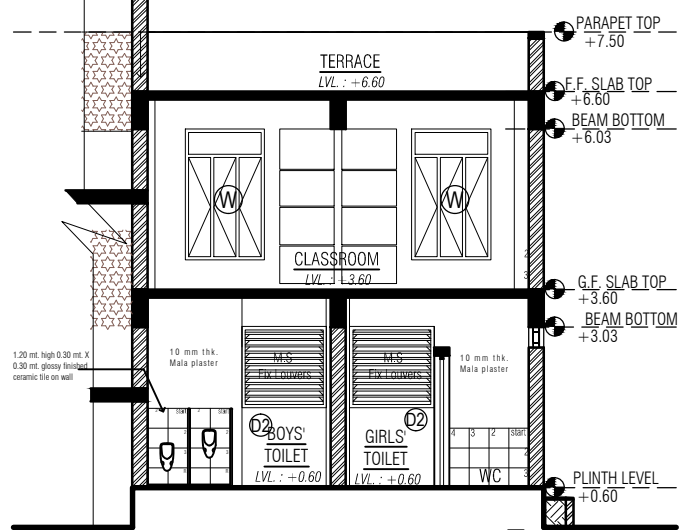

TOILET DETAIL - SECTIONS

PROJECT		
7-L + TOILET - REVISE		
S.S.A	DRAWN BY : NIRALI PANDYA	DRG.NO.
	SCALE : N.T.S.	1/8
	DATE : 18/5/17	

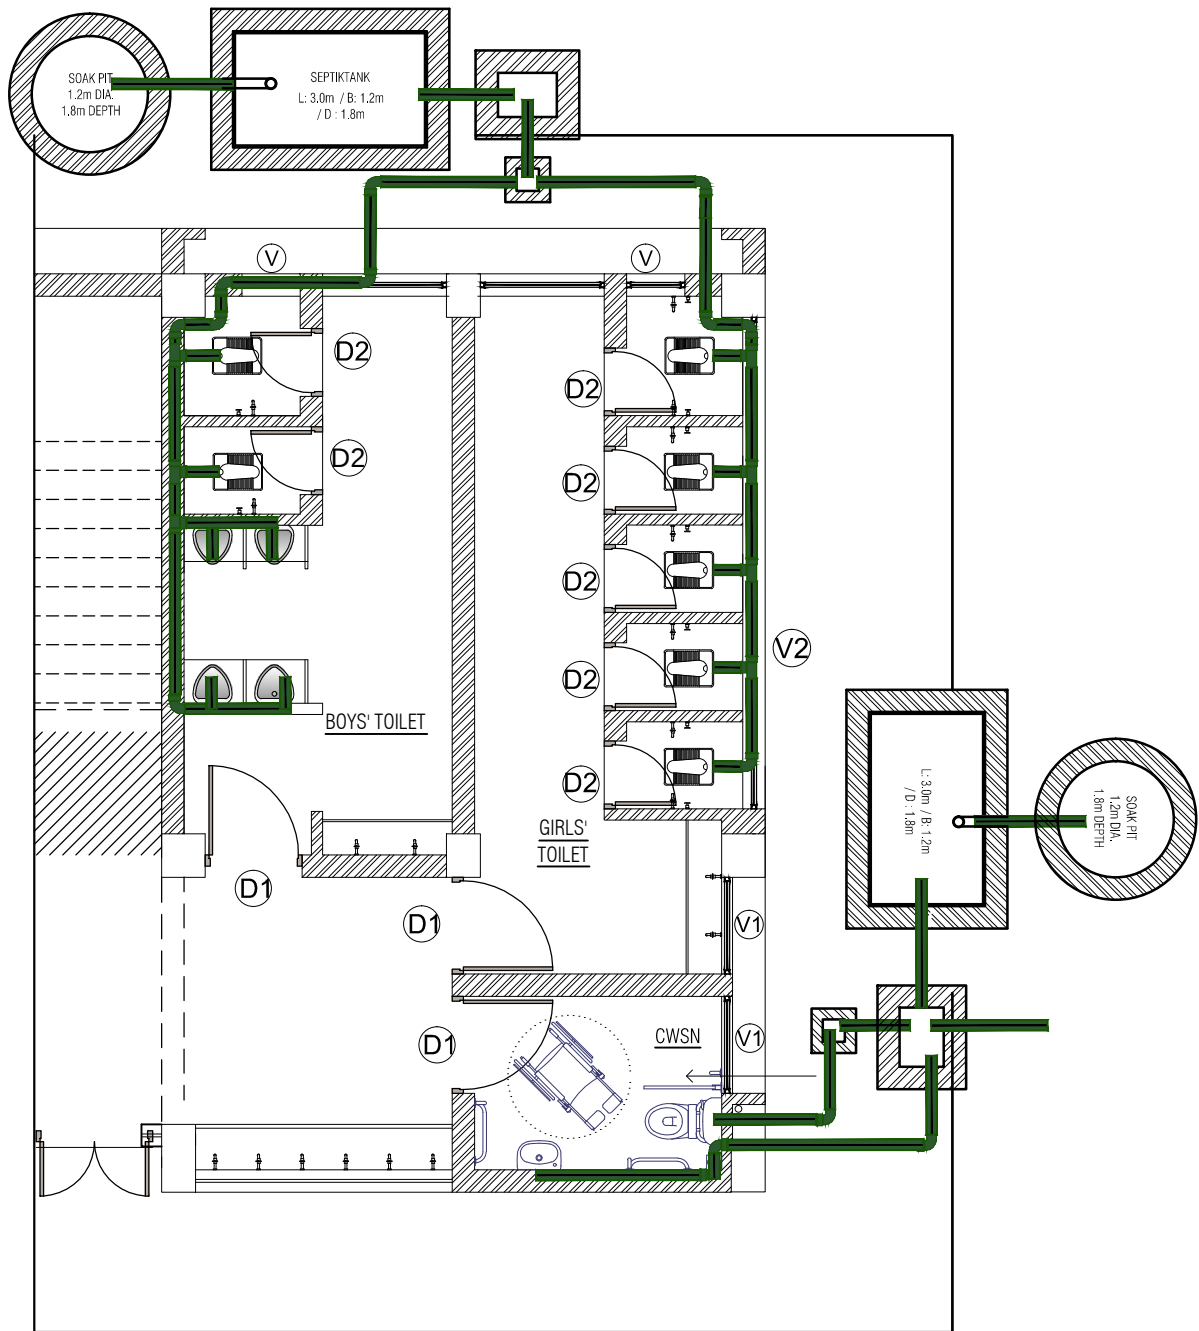

GROUND FLOOR PLAN


DRAINAGE LAYOUT

PROJECT
7-L + TOILET - REVISE

S.S.A
ARCHITECT
SAUMIL GAJJAR

DRAWN BY : NIRALI PANDYA
SCALE : N.T.S.
DATE :

DRG.NO.
5/8

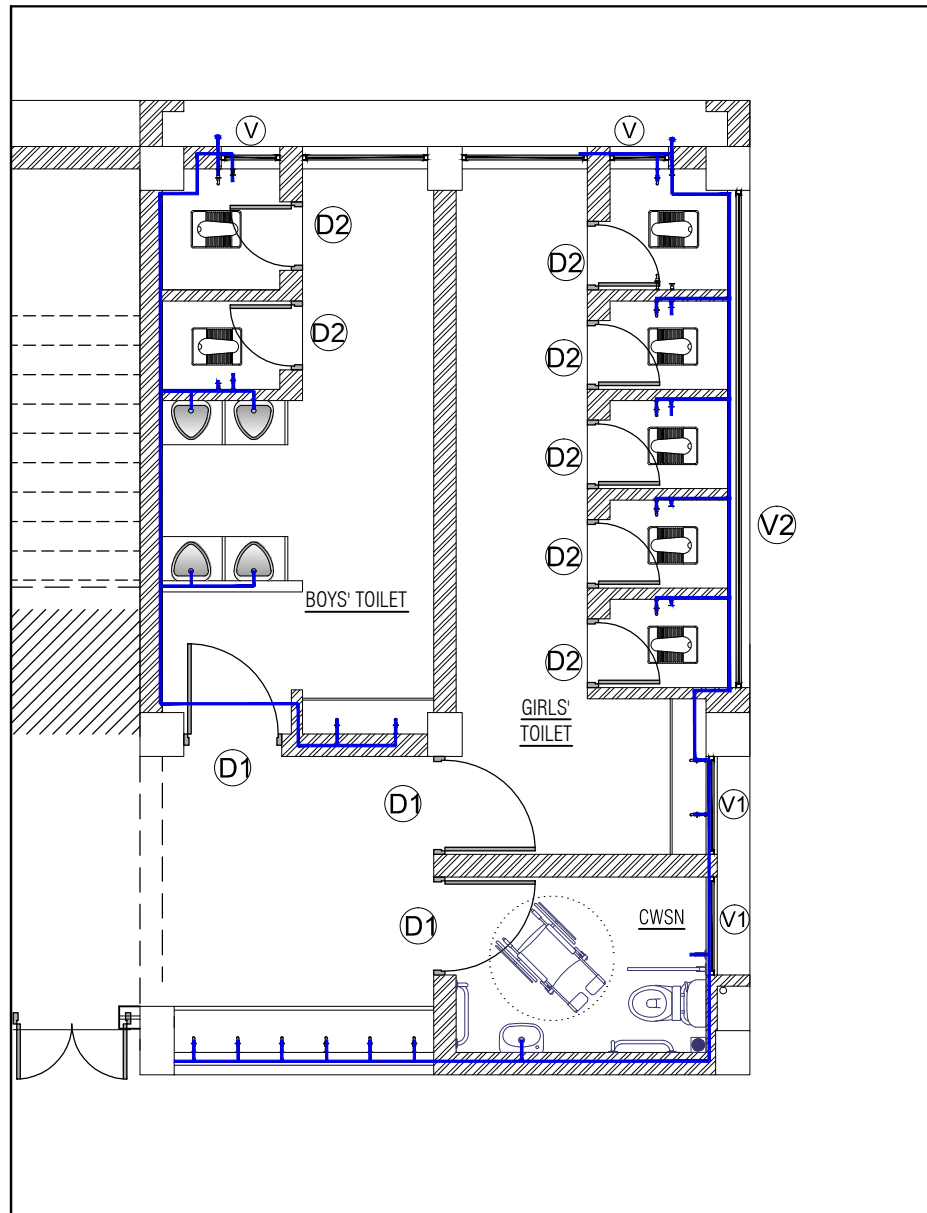

GROUND FLOOR PLAN

WATER SUPPLY LAYOUT

PROJECT
7-L + TOILET - REVISE

S.S.A
ARCHITECT
SAUMIL GAJJAR

DRAWN BY : NIRALI PANDYA
SCALE : N.T.S.
DATE :

DRG.NO.
5/8